


lots	6000mm	LX 6 (Cyc)	#33
	7000mm	Full Black	#32
	7000mm	Legs - 4	#31
	1000		#30
200Kg	4900mm	LX5	#29
	1000		#28
	1000		#27
	5800mm	Soft Header - 3	#26
50Kg	5000mm	LX 4	#25
	Grid		#24
50Kg	5200mm	LX 3	#23
	7000mm	Legs - 3	#22
50Kg	540mm	LX 2	#21
	Grid		#20
170kg	6000mm	LX 1	#19
	Grid		#18
	5800mm	Soft Header - 2	#17
	N/a	Moing Sreen G	#16
	7000mm	Legs - 2	#15
	N/a	Moving Screen F	#14
	Grid		#13
	N/a	Moving Screen E	#12
	7000mm	Legs - 1	#11
	N/a	Moving Screen D	#10
	5800mm	Soft Header - 1	#09
	N/a	Moving Screen C	#08
	Grid		#07
	N/a	Moving Screen B	#06
	Grid	Cyc - Storage	#05
	N/a	Moving Screen - A	#04
	5000mm	FIXED VENUE-Hard Header	#03
	7000mm	FIXED VENUE-House Curtains	#02
	7000mm	Significant limitations - wheels fitted	#01

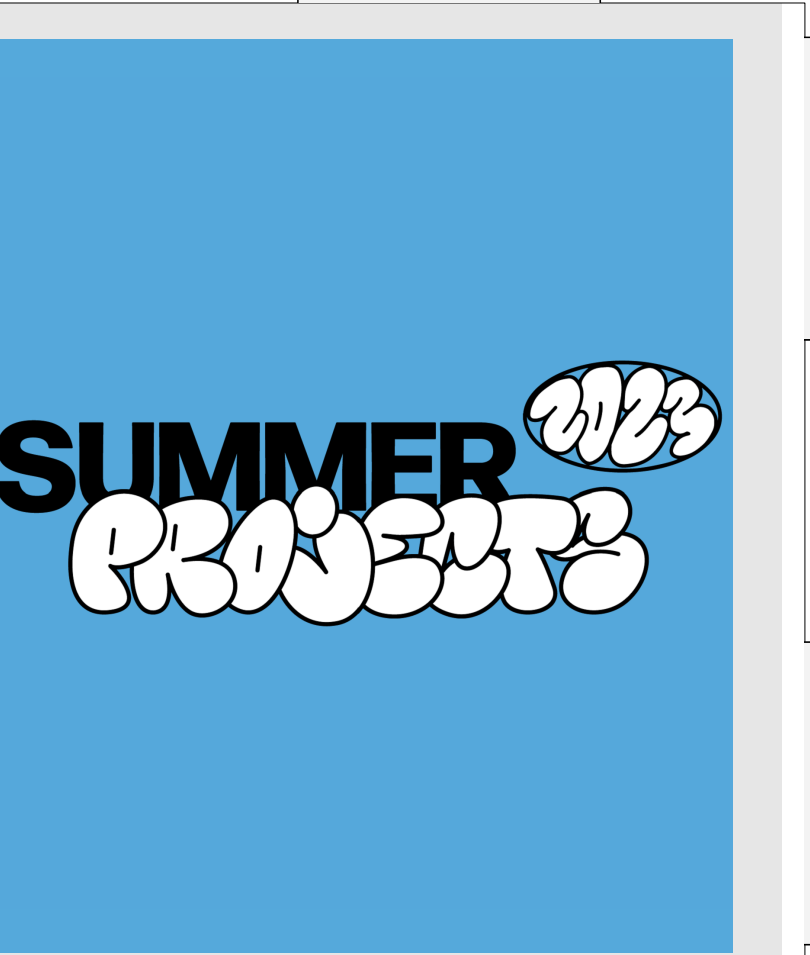

- Moving Lights**
- Light Instr Robe T1 Profile
  - OH-Light Instr Martin MAC TW
  - OH-Light Instr Martin MAC TW1 Narrow
  - OH-Light Instr GLP Impression X4 Bar 20
  - ETC Revolution
  - OH-Light Instr Elation Fuze Profile
  - OH-Light Instr Robe LEDBeam 150
- Intelligent**
- OH-Light Instr ETC Source 4 LEDLS 36deg
  - ETC Source4 LED 19deg
  - Martin Atomic 3000 DMX
- Generic**
- Robert Juliat 614 SX
  - OH-Altman LUI
  - OH-Light Instr ETC Source 4 14deg
  - OH-Light Instr ETC Source 4 26deg
  - OH-Light Instr ETC Source 4 50deg
  - OH-Par CP60
- Accessory**
- 6.25in Top Hat

**Summer Projects 2023**

Director..... N/a  
 Set Designer..... N/a  
 Costume Designer.... N/a  
 Lighting Designer.... Oliver Hynds  
 Sound Designer..... Sound Designer  
 Video Designer..... Various

Production Manager Jamie Hulme

Assicant LD..... N/a  
 Prod LX..... James Callis  
 Programmer..... Finn Rowden

**Revisions**

Ver	Date	Updates
A	29/04/2023	Initial for Prod
B	02/05/2023	Added Chans
C	05/05/2023	Major Truss Update
D	09/05/2023	Extra Ground Fixtures

**Oliver Hynds**  
 London, England oliverhynds.com  
 07970 219271 oliver.hynds@gmail.com

THIS PLAN IS TO INDICATE DESIGN INTENT ONLY AND DOES NOT IMPLY ANY METHODS BY WHICH THIS MAY BE ACHIEVED. THE LIGHTING DESIGNER ACCEPTS NO RESPONSIBILITY FOR ANY IMPROPER ENGINEERING CAUSED AS A RESULT OF THIS PLAN.



**MS - Overhead**  
 Sht-1  
 Page 1 of 4


**LIGHTING PLAN**  
 Milton Court Theatre, 1 Milton St, London EC2Y 9BH

Drawn by:  
 VWX File: Moving Screens Version Ev23vwx.vwx  
 Page Size: A0  
 Scale: 1:25

**KEY**

- Gel → L201
- Purpose → Kabuki 36°
- Unit Number → 201
- Channel → 201



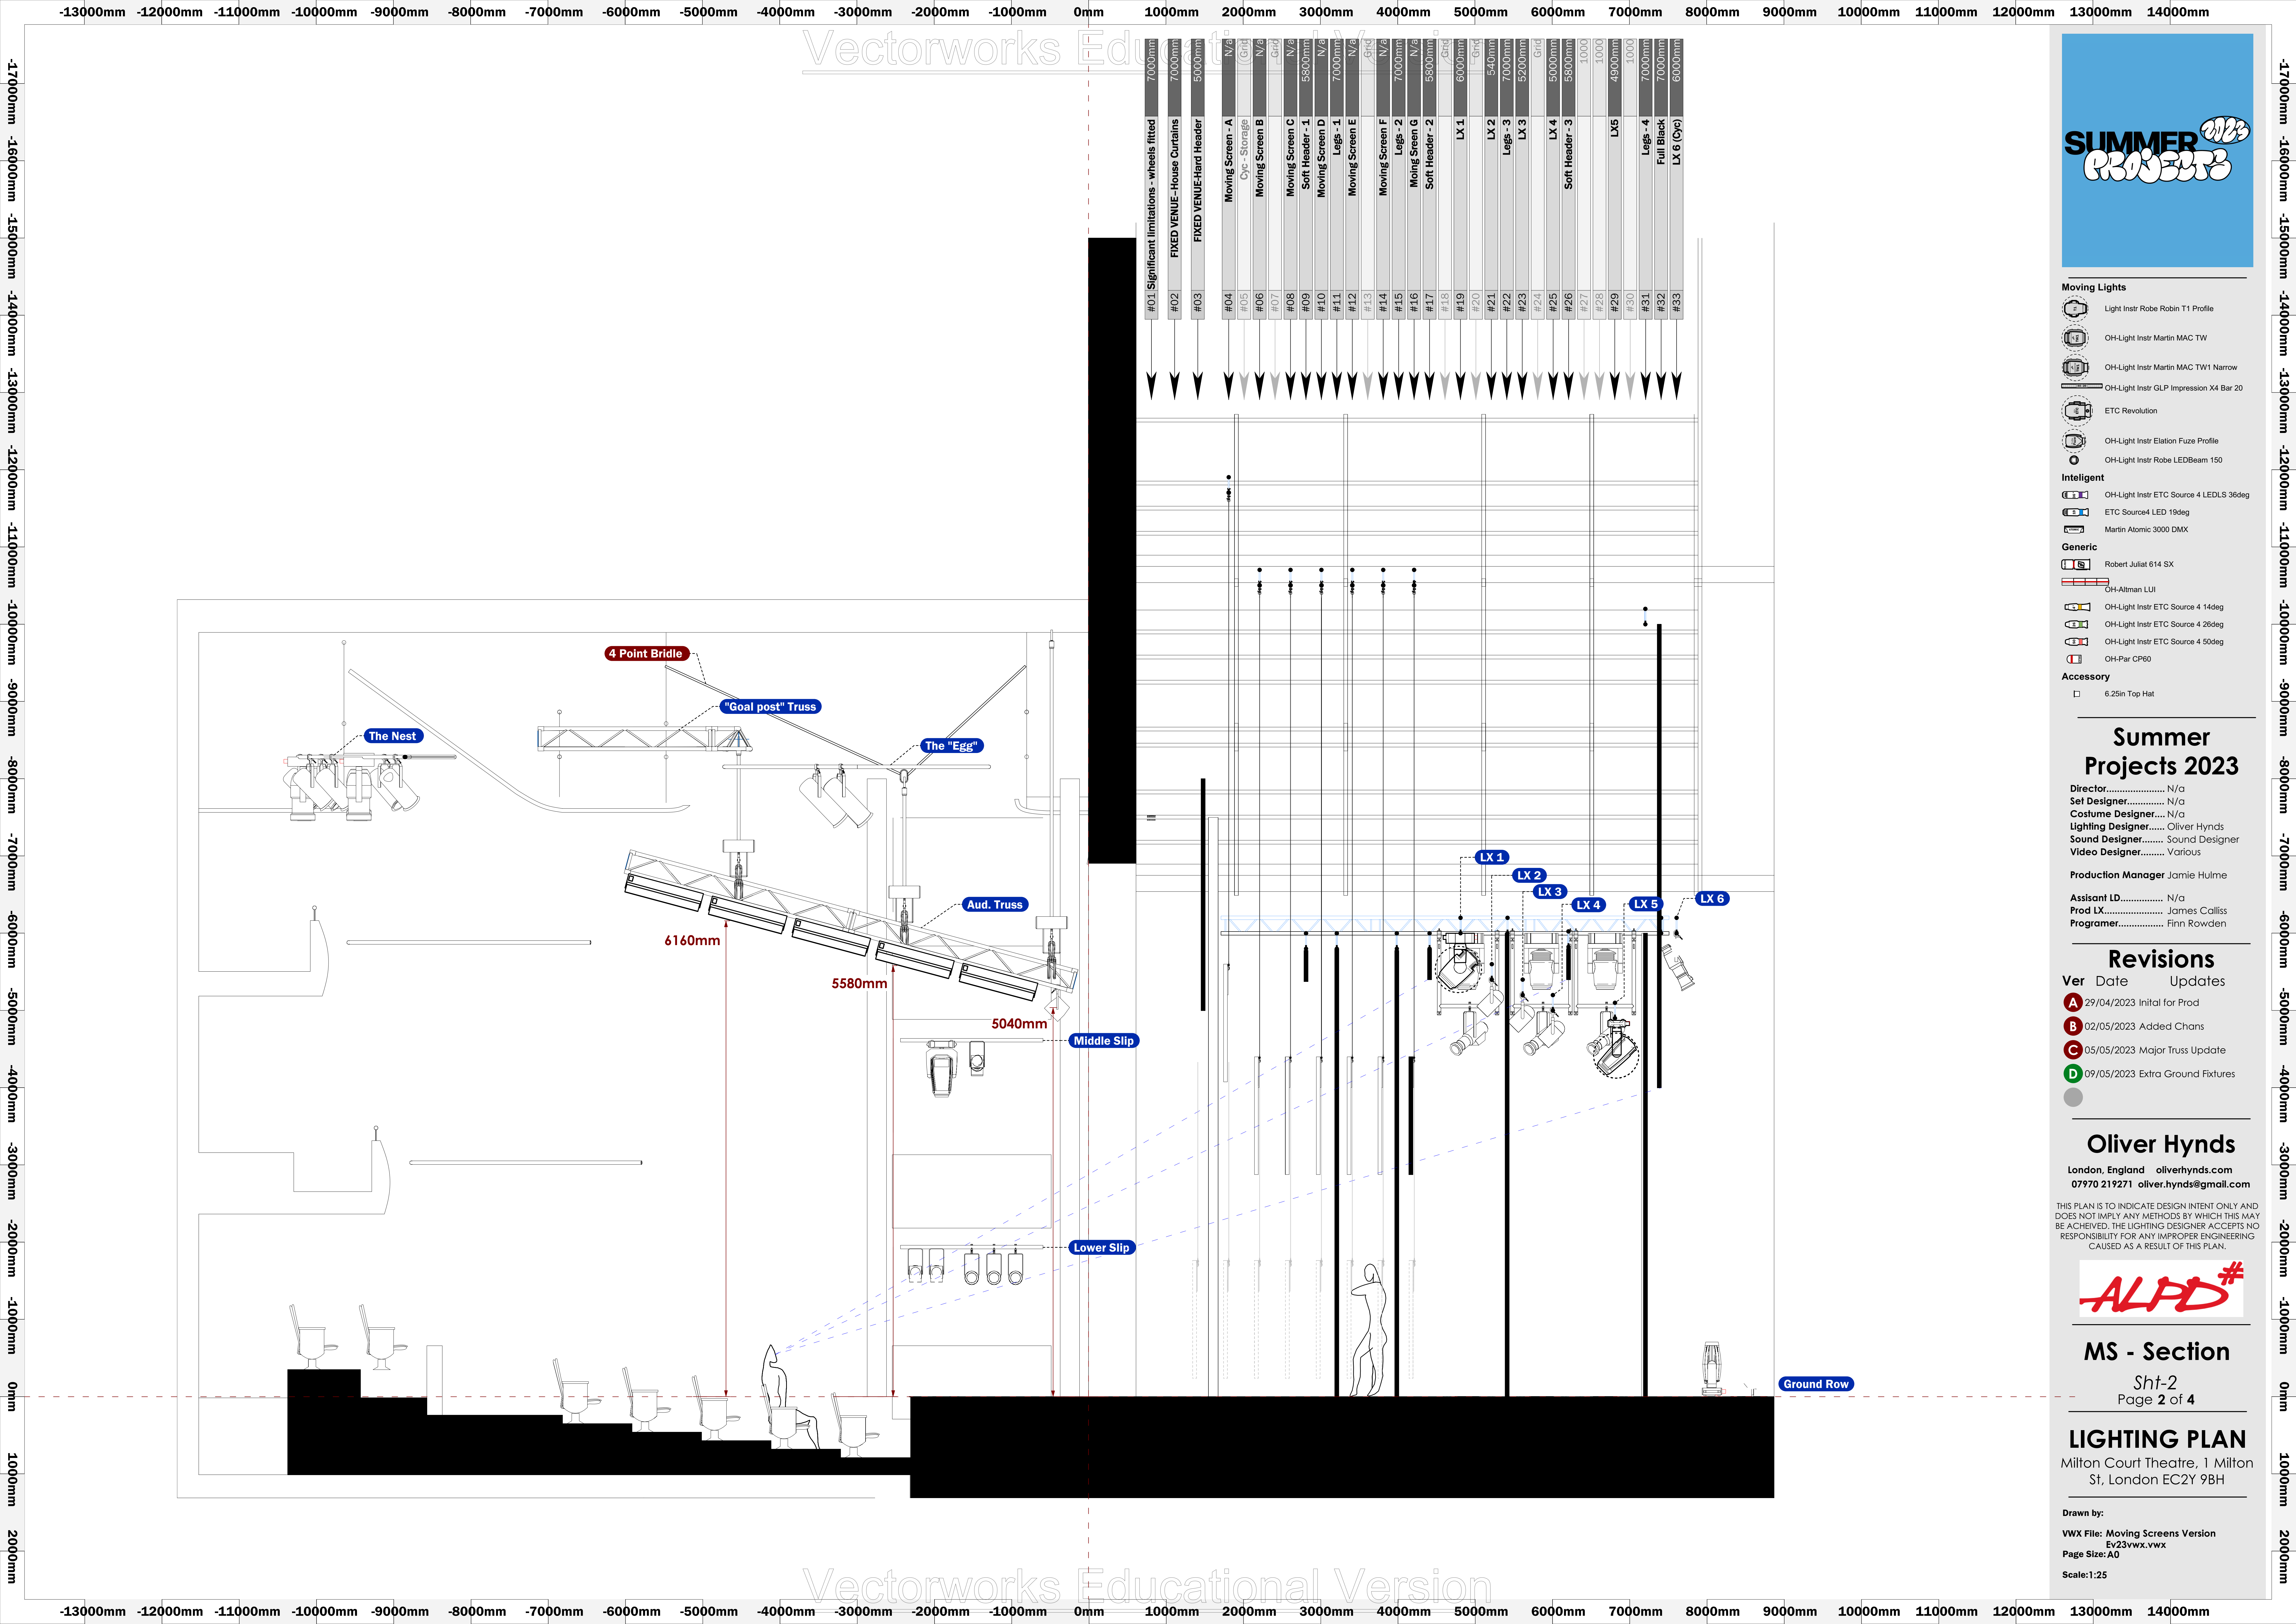

# SUMMER PROJECTS 2023

- Moving Lights**
- Light Instr Robe T1 Profile
  - OH-Light Instr Martin MAC TW
  - OH-Light Instr Martin MAC TW1 Narrow
  - OH-Light Instr GLP Impression X4 Bar 20
  - ETC Revolution
  - OH-Light Instr Elation Fuze Profile
  - OH-Light Instr Robe LEDBeam 150
- Intelligent**
- OH-Light Instr ETC Source 4 LEDLS 36deg
  - ETC Source4 LED 19deg
  - Martin Atomic 3000 DMX
- Generic**
- Robert Juliat 614 SX
  - OH-Altman LUI
  - OH-Light Instr ETC Source 4 14deg
  - OH-Light Instr ETC Source 4 26deg
  - OH-Light Instr ETC Source 4 50deg
  - OH-Par CP60
- Accessory**
- 6.25in Top Hat

**Summer Projects 2023**

Director..... N/a  
 Set Designer..... N/a  
 Costume Designer.... N/a  
 Lighting Designer..... Oliver Hynds  
 Sound Designer..... Sound Designer  
 Video Designer..... Various

Production Manager Jamie Hulme

Assisant LD..... N/a  
 Prod LX..... James Calliss  
 Programmer..... Finn Rowden

**Revisions**

Ver	Date	Updates
A	29/04/2023	Initial for Prod
B	02/05/2023	Added Chans
C	05/05/2023	Major Truss Update
D	09/05/2023	Extra Ground Fixtures

**Oliver Hynds**  
 London, England oliverhynds.com  
 07970 219271 oliver.hynds@gmail.com

THIS PLAN IS TO INDICATE DESIGN INTENT ONLY AND DOES NOT IMPLY ANY METHODS BY WHICH THIS MAY BE ACHIEVED. THE LIGHTING DESIGNER ACCEPTS NO RESPONSIBILITY FOR ANY IMPROPER ENGINEERING CAUSED AS A RESULT OF THIS PLAN.



**MS - Section**  
 Sht-2  
 Page 2 of 4

**LIGHTING PLAN**  
 Milton Court Theatre, 1 Milton St, London EC2Y 9BH

Drawn by:  
 VWX File: Moving Screens Version  
 Ev23vwx.vwx  
 Page Size: A0  
 Scale: 1:25